


"THE DIMENSIONS ON THIS FLOOR PLAN DRAWING ARE FOR GENERAL LAYOUT PURPOSES ONLY. PRECISE DIMENSIONAL DETAILS FROM DESIGN DRAWINGS CAN BE SUPPLIED UPON REQUEST."

DRAWING NUMBER:
5006CFP

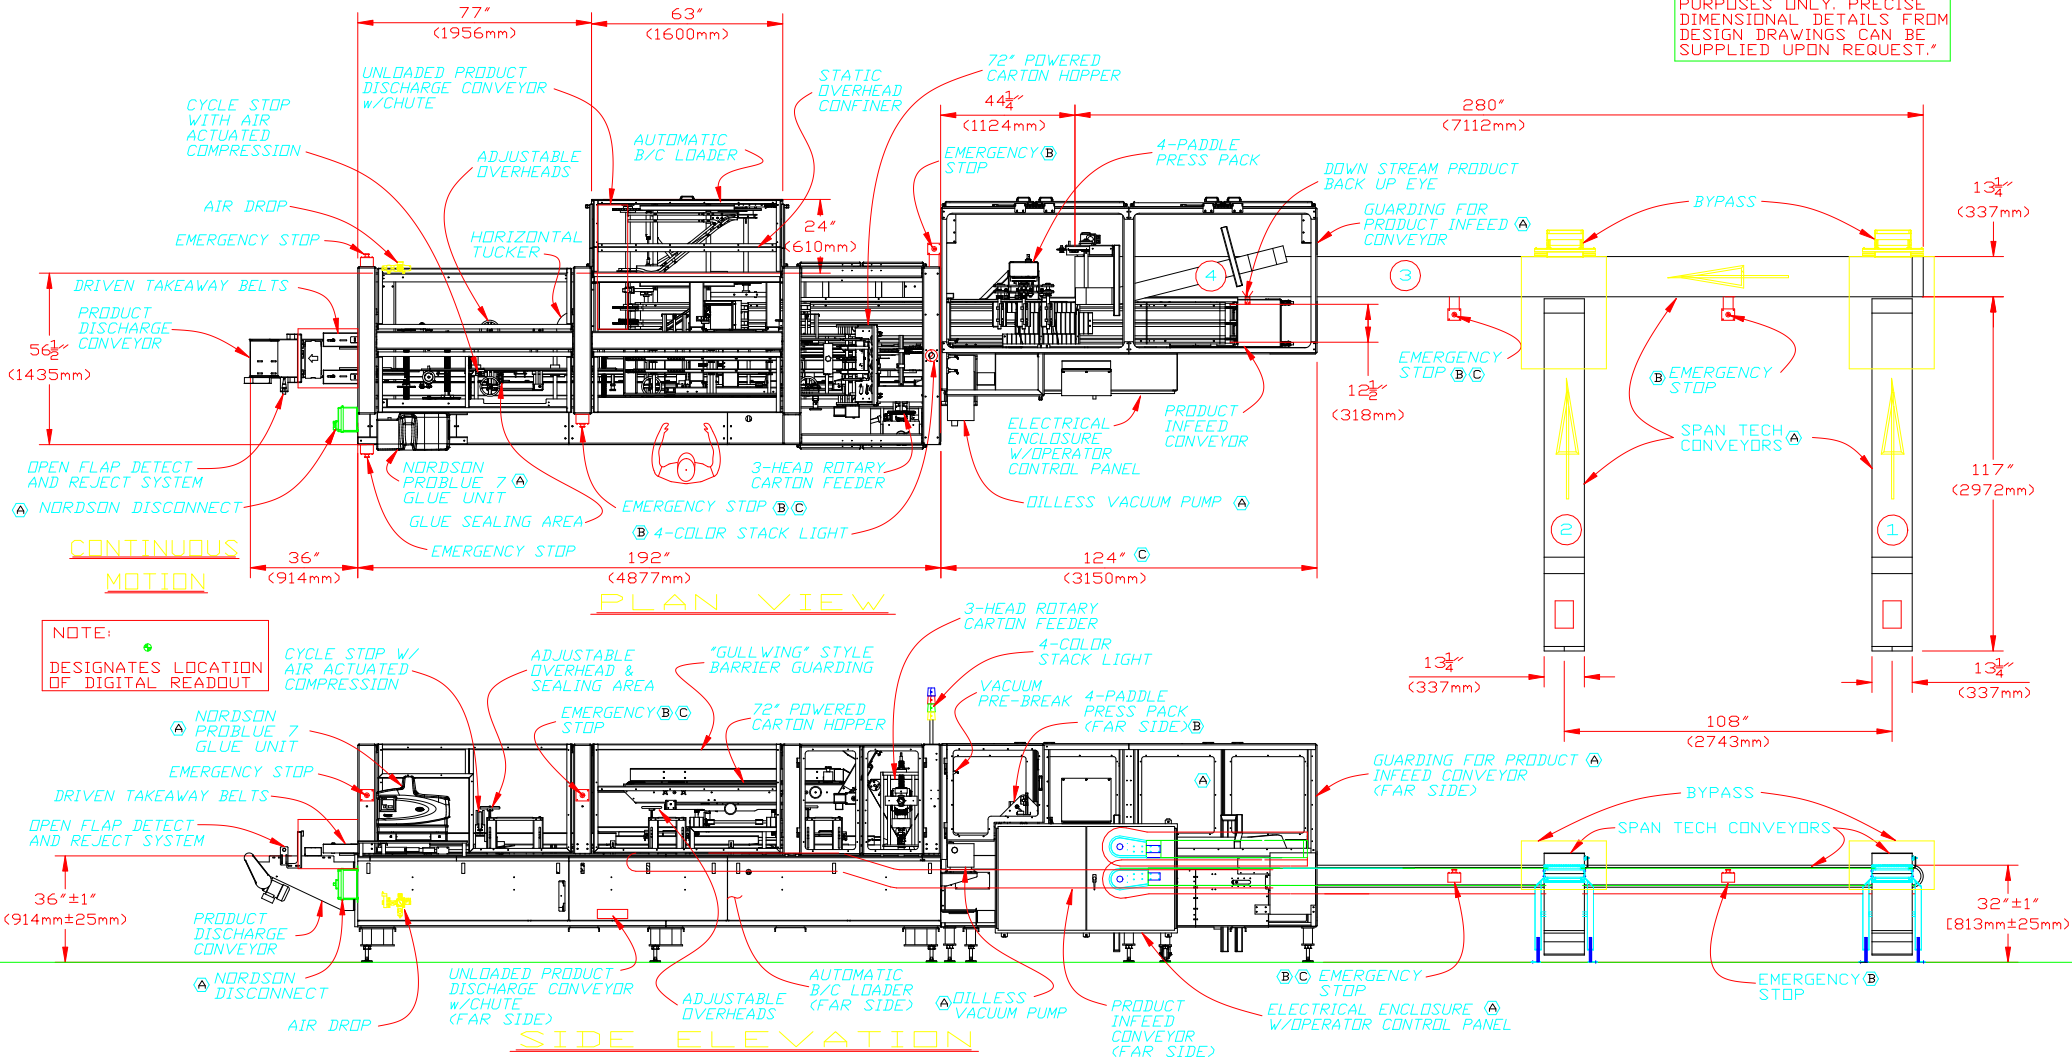

7/02/08	(C)	RELOCATE EMERGENCY STOP LOCATION; UPDATE MACHINE LAYOUT FOOTPRINT	DD	JKY
5/16/08	(B)	SHOW TWO (2) EMERGENCY STOP LOCATIONS; RELOCATE ONE EMERGENCY STOP; REMOVE ADDITIONAL ELECTRICAL ENCLOSURE FROM FLOOR PLAN	DD	JKY
3/06/08	(A)	ADD GUARDING AROUND INFEED CONVEYOR; LABEL SPAN TECH CONVEYORS; ADD SECOND ELECTRICAL ENCLOSURE; CHANGE ORIENTATION OF VACUUM PUMP; AND CHANGE LOCATION OF NORDSON GLUE UNIT AND NORDSON DISCONNECT	CAW	JKY
DATE	SYM	NOTES	AUTH	BY

APPROVED

BY: _____
DATE: _____
TITLE: _____

NOTE: MANUFACTURING OF THIS
EQUIPMENT WILL NOT BEGIN UNTIL
RECEIPT OF THIS APPROVED PRINT.

SALES DEPT.

BYL

DATE:

ENGINEER DEPT.

BYL

DATE:

COMMENTS:

ADCO ENGINEERING DATA: DIMENSIONS ARE APPROXIMATE

QUOTE:12456F,RTC MAX CPM:125

DESCRIPTION OF PRODUCT:	BAGS OF PRETZELS
-------------------------	------------------

CARTON SIZE(S): A>5-3/8" x 2-5/8" x 8-1/8

B)

VOLTAGE: 480v/3ph/60hz AMPERAGE (EST.): 1

AIR REQUIREMENT: 2-3 CFM @ 65-70 PSI
WATER REQUIREMENT: NONE

WATER REQUIREMENTS	NONE
--------------------	------



2170 ACADEMY
SANGER,CALIFORNIA 93657
(559) 875-5563

DRAWN BY: JKY
TAINLESS STEEL FRAME

FLOOR PLAN - 12BC-125-SS

BAPTISTA'S